

DESIGNER IS NOT AN ARCHITECT OR ENGINEER.  
SITE CONDITIONS MAY VARY. DESIGNER CANNOT  
WARRANT THE SUITABILITY OF THESE PLANS FOR  
YOUR SPECIFIC SITE. CONSULT YOUR CONSTRUCTION  
PROFESSIONAL TO DETERMINE THE SUITABILITY OF  
THESE PLANS FOR YOUR SPECIFIC SITE.

OLIVIA

ALL RIGHTS  
© 2021  
RESERVED


Residential Design Services  
402-592-6968

TRK  
& Associates

29218

7 OF 7

ELECTRICAL LEGEND	
<b>OUTLETS</b>	<b>SWITCHES</b>
⊖ 10 VOLT	Ⓢ TWO-WAY
⊖ 220 VOLT	Ⓢ <sub>3</sub> THREE-WAY
⊖ SW. 10	Ⓢ <sub>4</sub> FOUR-WAY
⊖ <sup>GF</sup> GROUND FALT	<b>MISC. FIXTURES</b>
⊖ <sup>GF</sup> <sub>W.P.</sub> GROUND FALT WEATHER-PROOF	
⊖ FLOOR OUTLET	⊖ CLG. FAN/LIGHT COMBINATION
<b>LIGHTING</b>	⊖ EXHAUST FAN
⊖ WALL MOUNT	⊖ FAN/CAN COMBINATION
⊖ SURFACE MOUNT	⊖ SMOKE DETECT. CLG. MOUNT
⊖ RECESSED CAN	⊖ SMOKE DETECT. WALL MOUNT
⊖ FULL-CORD SURFACE	⊖ THERMOSTAT
⊖ FLOURESCENT	

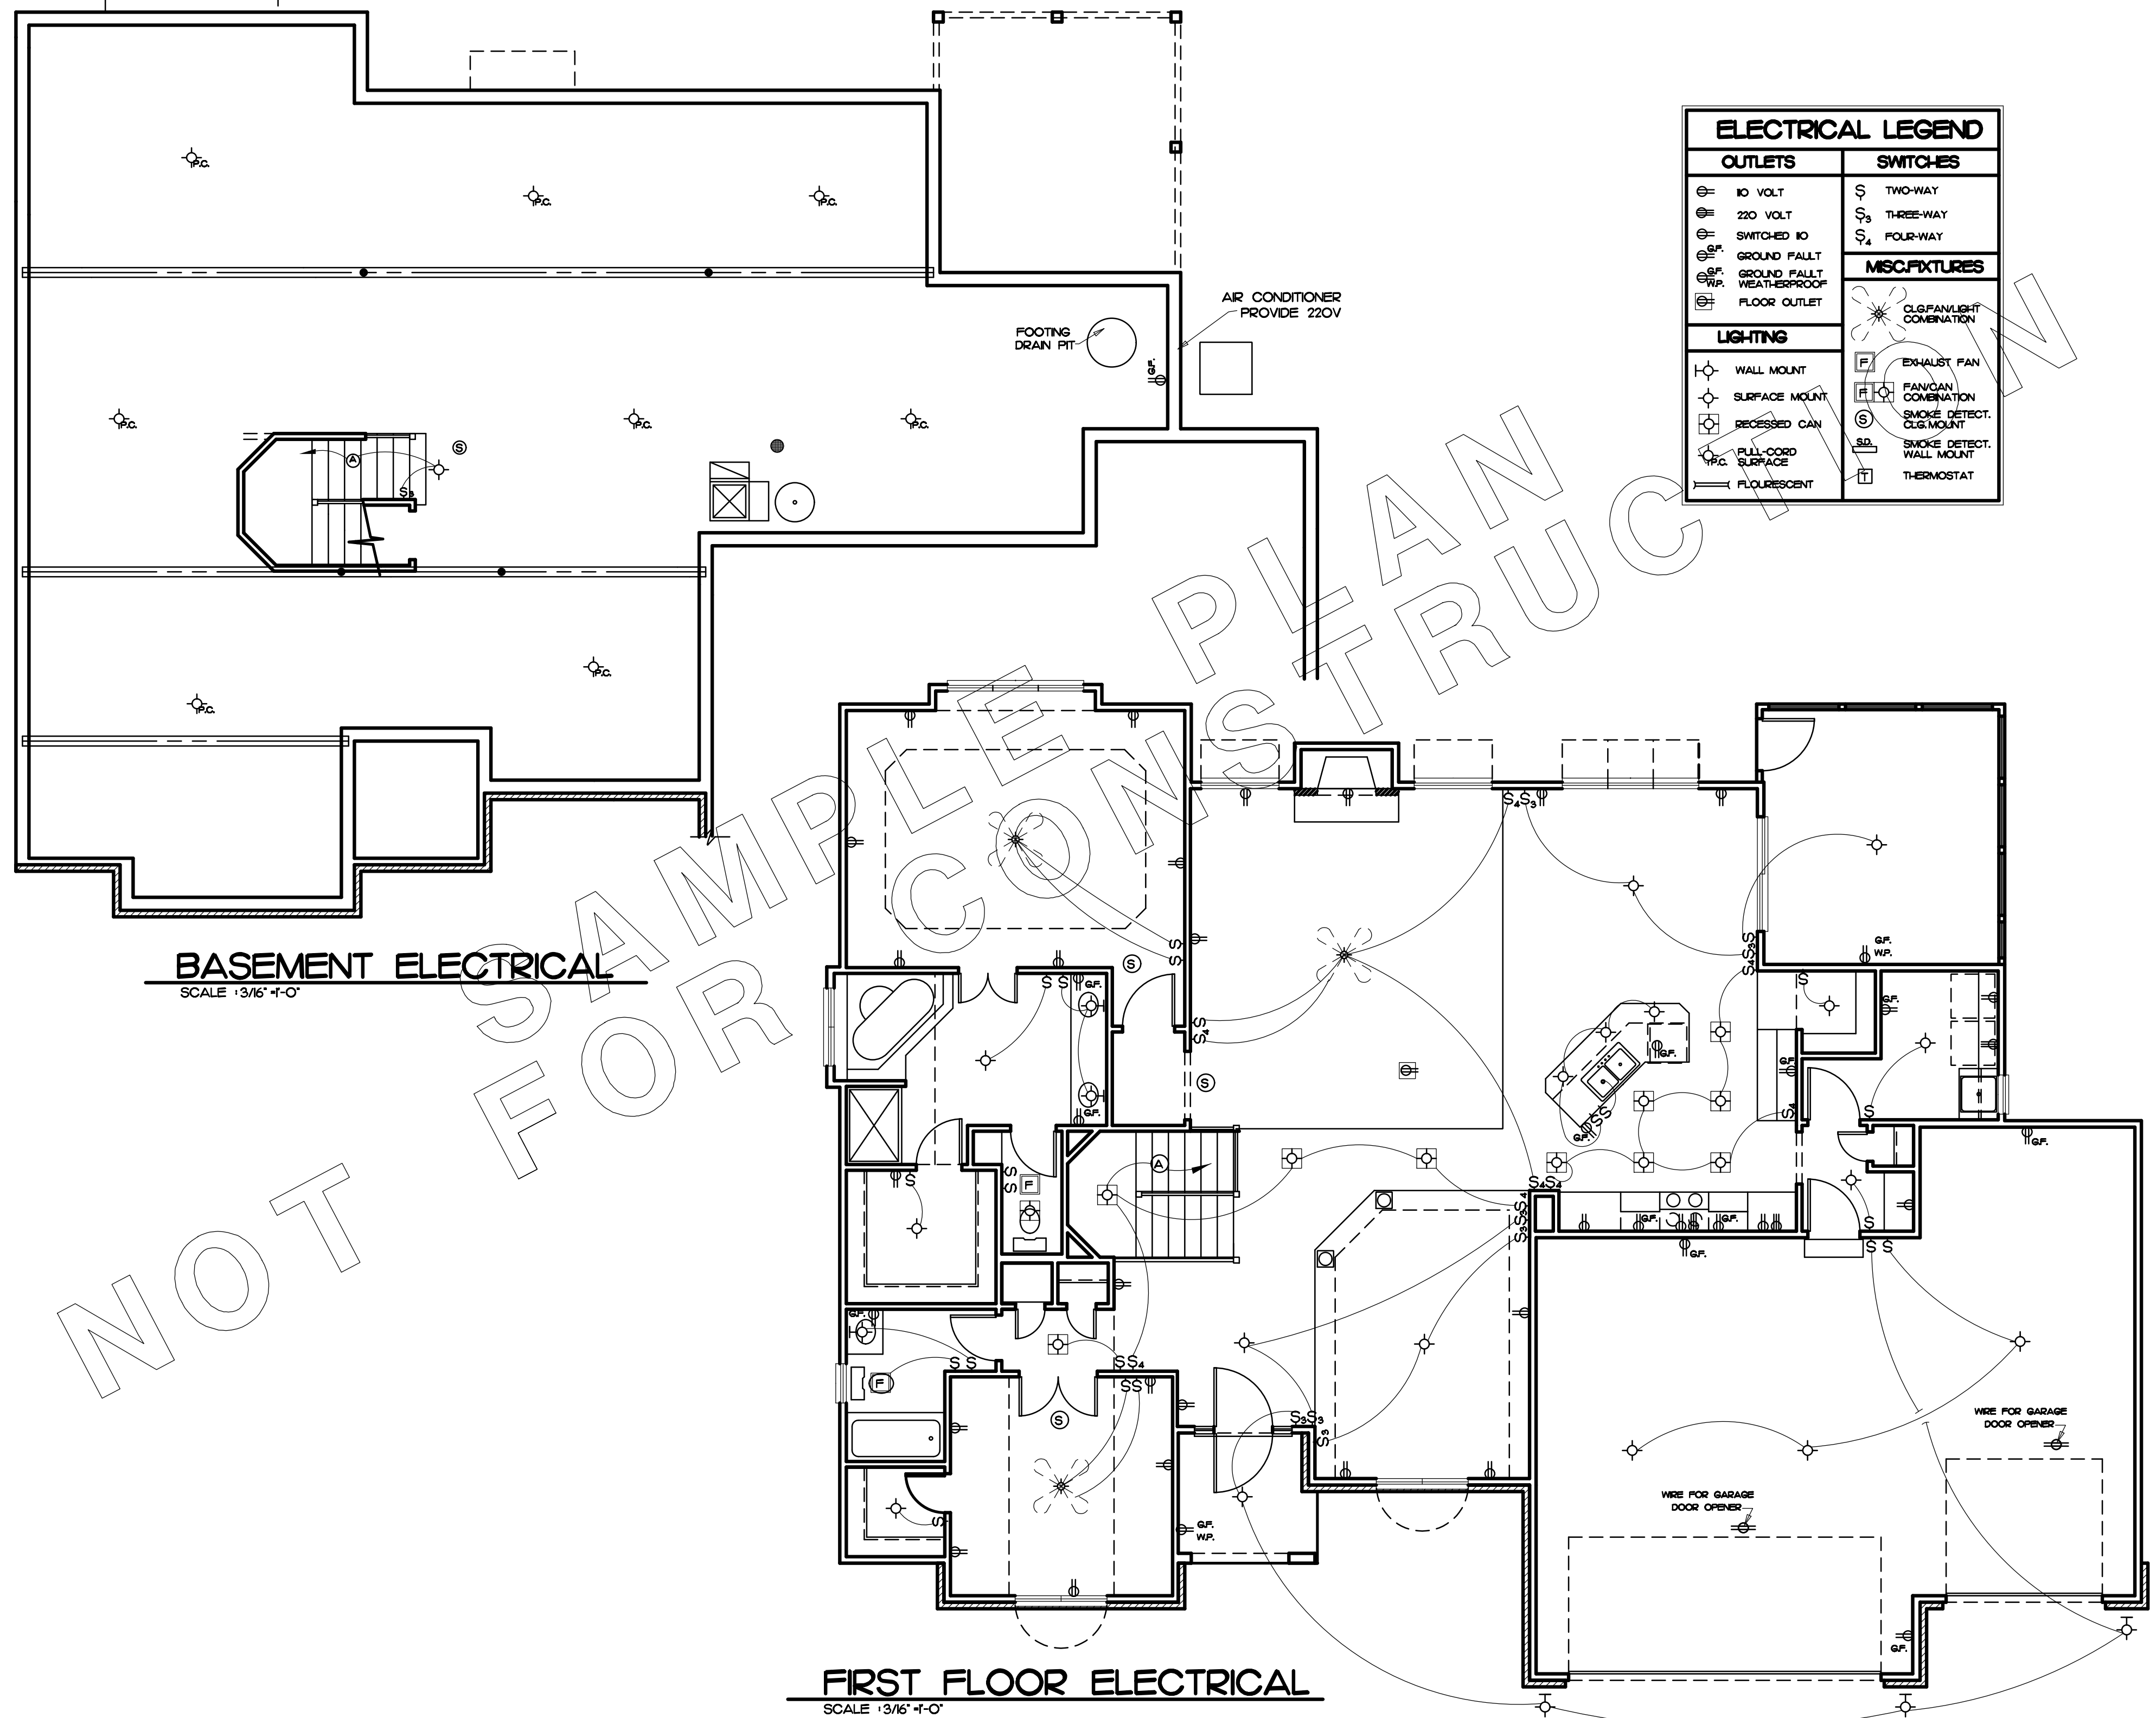

**BASEMENT ELECTRICAL**  
SCALE 1/32" = 1'-0"

**FIRST FLOOR ELECTRICAL**  
SCALE 1/32" = 1'-0"

AIR CONDITIONER  
PROVIDE 220V

FOOTING  
DRAIN PIT

WIRE FOR GARAGE  
DOOR OPENER

WIRE FOR GARAGE  
DOOR OPENER